


擬建公共屋邨  
PROPOSED PUBLIC HOUSING ESTATE

INSULATED WINDOWS AND AIR-CONDITIONING FOR 6 SPECIAL ROOMS FROM THE 2/F TO 7/F AND 3 SMALL GROUP TEACHING ROOMS FROM THE 5/F TO 7/F AT THE WESTERN FACADE OF THE SPECIAL ROOM BLOCK  
在特別室大樓向西一面2樓至7樓的6間特別室及5樓至7樓的3間小組教學室裝置隔音窗及空調

CONSTRUCTION OF 3-METRE HIGH BOUNDARY WALL AT THE NORTHERN SIDE OF THE SITE  
在校址北面建造三米高的圍牆

INSULATED WINDOWS AND AIR-CONDITIONING FOR 12 CLASSROOMS FROM THE 1/F TO 6/F AT THE EASTERN FACADE OF THE CLASSROOM BLOCK  
在課室大樓向東一面1樓至6樓的12間課室裝置隔音窗及空調

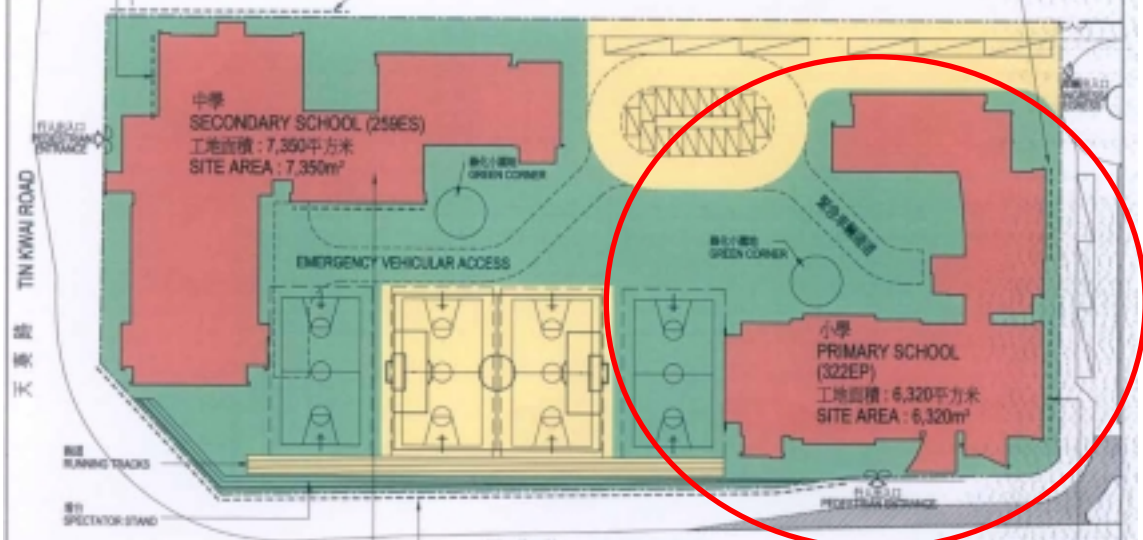

INSULATED WINDOWS AND AIR-CONDITIONING FOR 12 CLASSROOMS FROM THE 2/F TO 5/F AT THE SOUTHERN FACADE OF THE CLASSROOM BLOCK  
在課室大樓向南一面2樓至5樓的12間課室裝置隔音窗及空調

CONSTRUCTION OF A 3-METRE HIGH BOUNDARY WALL AT THE SOUTHERN SIDE OF THE SITE  
在校址南面建造三米高的圍牆

INSULATED WINDOWS AND AIR-CONDITIONING FOR 4 SPECIAL ROOMS ON THE 3/F, 4/F AND 6/F AT THE EASTERN FACADE OF THE SPECIAL ROOM BLOCK  
在特別室大樓向東一面3樓、4樓及6樓的4間特別室裝置隔音窗及空調

title 259ES AND 322EP 天水圍第104區的 第2所中學和第2所小學 SECOND SECONDARY SCHOOL AND SECOND PRIMARY SCHOOL IN AREA 104, TIN SHUI WAI	drawn by 林恩慈 LAM YAN CHIT	date 18.01.04	drawing no. AB/6482/NM-01	scale 1:1000
	approved 黎經聖 REMBERT S.K. LAI	date 18.01.04	ARCHITECTURAL SERVICES DEPARTMENT	
	office ARCHITECTURAL BRANCH			